

COVER

Building Permit - Unit Type A

124-126 Lockhart St, Como, WA 6152

CONTENT		
B0.00	Cover Page	
B1.01	Floor Plans	1:100
B1.02	Floor Plans	1:100
B1.03	Internal Finishes	1:50
B2.01	Elevations and window schedule	1:50
B3.01	Sections	1:50
B3.02	Stairs + Lift details	1:50
B4.01	Details	
B4.02	Details	

GENERAL NOTES

1.ALL DIMENSIONS ARE IN MILLIMETRES U.N.O.

2.WRITTEN DIMENSIONS SHALL TAKE PRECEDENCE OVER SCALED DIMENSIONS.

3.CONTRACTORS SHALL CARRY OUT WORK IN CONFORMANCE WITH B.C.A.N.C.C RELEVANT STANDARDS AND THE LOCAL AUTHORITY REQUIREMENTS.

4.THE MAIN CONTRACTOR IS TO ENSURE THIS DRAWING IS READ IN CONJUNCTION WITH ALL RELEVANT ARCHITECTURAL, STRUCTURAL AND SERVICE CONSULTANT DOCUMENTATION TO ENSURE FULL CO-ORDINATION BETWEEN TRADES PRIOR TO WORK COMMENCEMENT.

5.LARGE SCALE DRAWINGS SHALL TAKE PRECEDECE OVER SMALL SCALE DRAWINGS.

6.SEEK CLARIFICATION FROM SUPERINTENDENT FOR ANY DISCREPANCY.

7.ALL EXTERNAL FLOOR SURFACES TO FALL AWAY FROM BUILDING.

8.REFER INTERIOR DOCUMENTATION FOR SETOUTS AND EXACT LOCATION OF CABINETRY, FITTINGS, FIXTURES, PLUMBING, FLOOR WASTES AND TILING.

9. ALL MATERIALS SHALL BE NEW AND CONFORM TO WHAT IS SHOWN ON THE DRAWINGS AND IN THE SCHEDULES.

10.THE CONTRACTORS SHALL CHEK AND VERIFY ALL DIMENSIONS ON SITE, PRIOR TO THE COMMENCEMENT OF ANY BUILDING WORK. ALL WINDOW DIMENSIONS ARE NOMINAL AND ARE TO BE MEASURED ON SITE.

11.THE CONTRACTOR SHALL VISIT THE SITE AND NOTE ALL SITE CONDITION AND ACCESS REQUIREMENTS.

12. REFER TO WALL TYPES PLANS FOR WALL AND STRUCTURAL COLUMN SETOURS.

13.REFER SLAB SETOUT PLANS FOR SLAB SETOUTS.

14.INSTALL FLASHINGS, EDGE TRIMS AND APPROPRIATE SEALS AS REQUIRED TO ACHIEVE WEATHER TIGHTNESS. FINISH TO BE SAME AS ADJACENT MATERIAL U.N.O.

15.REFER MASTER MATERIALS SCHEDULE FOR THE FOLLOWING BUILDING TAGS:

- STRUCTURE SURFACE FINISHES

- FIXTURES AND FITTINGS

- FINISHES

- APPLIANCES

- TRIMS

- CEILINGS

DRAWN	CM	DESIGNED	zz
CHECKED	SM	PRINCIPAL	
DATE	31/08/2026	Principal	
PROJECT No.	630-GRI	DRAWING No.	REV.
Scale as shown - Half Scale @ A3		B0.00	Rev A

URBANIZE

(08) 6243 6405

0438420344

urbanize@urbanize.com.au

					CONTRACTOR TO CHECK ALL DIMENSIONS & LEVELS ON SITE BEFORE COMMENCING ANY WORK OR PREPARING ANY SHOP DRAWINGS.
					FIGURED DIMENSIONS TAKE PRECEDENCE OVER MEASUREMENTS MANUALLY SCALED OFF DRAWINGS.
					LARGE SCALE DWGS TAKE PRECEDENCE OVER SMALLER SCALE DWGS.
DATE	REV	REASON FOR ISSUE		BY	


COMO TOWNHOUSE DEVELOPMENT

124-126 Lockhart St, Como, WA 6152


Sheet Name

Cover Page


Building Permit

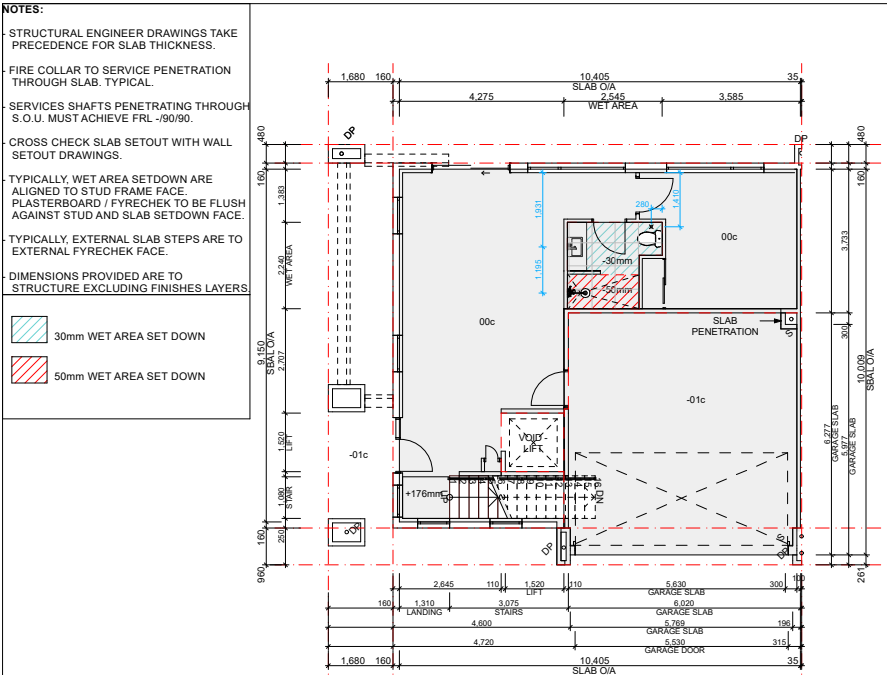


Ground Floor - Slab Setout Plan
Scale 1:100

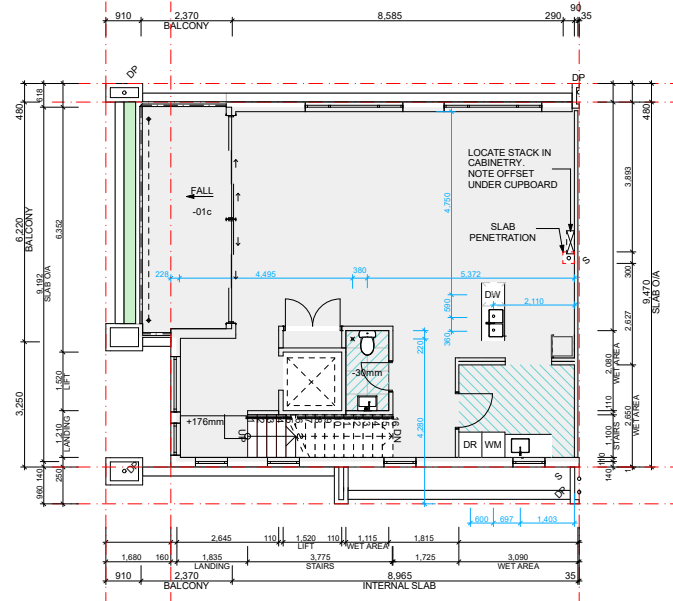

First Floor - Slab Setout Plan
Scale 1:100

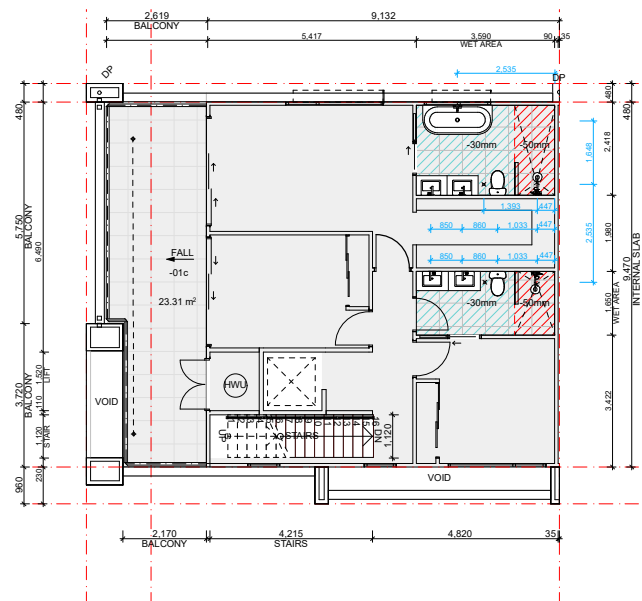

Second Floor - Slab Setout Plan
Scale 1:100

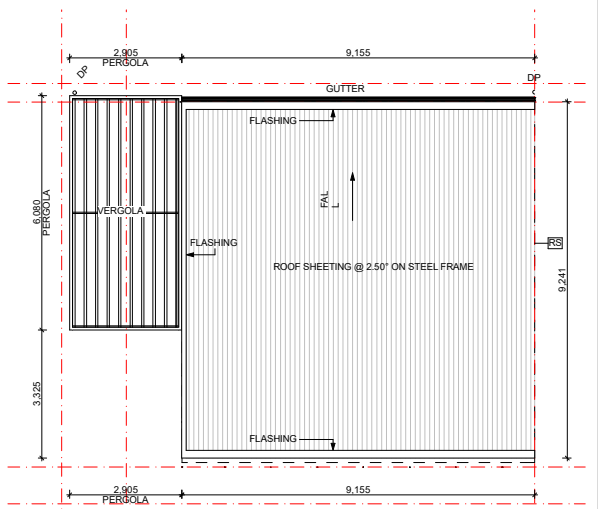

Roof Plan
Scale 1:100

GENERAL NOTES

- ALL DIMENSIONS ARE IN MILLIMETRES U.N.O.
- WRITTEN DIMENSIONS SHALL TAKE PRECEDENCE OVER SCALED DIMENSIONS.
- CONTRACTORS SHALL CARRY OUT WORK IN CONFORMANCE WITH 8 C.A.N.G.C. RELEVANT STANDARDS AND THE LOCAL AUTHORITY REQUIREMENTS.
- THE MAIN CONTRACTOR IS TO ENSURE THIS DRAWING IS READ IN CONJUNCTION WITH ALL RELEVANT ARCHITECTURAL, STRUCTURAL AND SERVICE CONSULTANT DOCUMENTATION TO ENSURE FULL CO-ORDINATION BETWEEN TRADES PRIOR TO WORK COMMENCEMENT.
- LARGE SCALE DRAWINGS SHALL TAKE PRECEDENCE OVER SMALL SCALE DRAWINGS.
- SEEK CLARIFICATION FROM SUPERINTENDENT FOR ANY DISCREPANCY.
- ALL EXTERNAL FLOOR SURFACES TO FALL AWAY FROM BUILDING.
- REFER INTERIOR DOCUMENTATION FOR SETOUTS AND EXACT LOCATION OF CABINETRY, FITTINGS, FIXTURES, PLUMBING, FLOOR WASTES AND TILING.
- ALL MATERIAL S SHALL BE NEW AND CONFORM TO WHAT IS SHOWN ON THE DRAWINGS AND IN THE SCHEDULES.
- THE CONTRACTORS SHALL CHEK AND VERIFY ALL DIMENSIONS ON SITE, PRIOR TO THE COMMENCEMENT OF ANY BUILDING WORK. ALL WINDOW DIMENSIONS ARE NOMINAL AND ARE TO BE MEASURED ON SITE.
- THE CONTRACTOR SHALL VISIT THE SITE AND NOTE ALL SITE CONDITION AND ACCESS REQUIREMENTS.
- REFER TO WALL TYPES PLANS FOR WALL AND STRUCTURAL COLUMN SETOURS.
- REFER SLAB SETOUT PLANS FOR SLAB SETOUTS.
- INSTALL FLASHINGS, EDGE TRIMS AND APPROPRIATE SEALS AS REQUIRED TO ACHIEVE WEATHER TIGHTNESS. FINISH TO BE SAME AS ADJACENT MATERIAL U.N.O.
- REFER MASTER MATERIALS SCHEDULE FOR THE FOLLOWING BUILDING TAGS:
 - STRUCTURE SURFACE FINISHES
 - FIXTURES AND FITTINGS
 - FINISHES
 - APPLIANCES
 - TRIMS
 - CEILING


NOTES:

- DIMENSIONS PROVIDED ON GENERAL ARRANGEMENT PLANS ARE TO WALL STRUCTURE**
- FLOOR PLANS:
 - OVERALL SETOUTS, WINDOW AND DOOR TYPES.
 - GENERAL UNIT LAYOUTS AND PLUMBING LOCATIONS
 - WALL TYPES:
 - FULL SETOUT OF WALLS AND WINDOWS, WALL TYPES TAGGED FOR REFERENCE
 - SLAB SETOUT:
 - LOCATION OF SLAB EDGES, SET DOWNS, PENETRATIONS AND PLUMBING SETOUT


WALL TYPES NOTES

- NOTES: EXTERNAL AND INTERNAL WALL TYPES**
- PROVIDE CAVITY FLASHINGS TO PREVENT MOISTURE INGRESS TO INTERIORS.
 - CUSTOM PROFILES COLORBOND PARAPET CAPPING, U.N.O.
 - COLORBOND OVER-FLASHING TO PARAPET WALL BETWEEN COLORBOND PARAPET CAPPING AND COLORBOND APRON-FLASHING, TYPICAL.
 - WATERPROOF MEMBRANE TO RETAINING WALLS, PLANTER WALLS, SHOWERS, BATHS AND OTHER AREAS AS REQUIRED.
 - COREFLUTE, GEOTEXTILE AND DRAINAGE CELLS TO INSIDE PLANTERS.
 - FINAL FINISHED WALL SURFACES OF LINING MATERIAL VARYING IN THICKNESS TO BE ALIGNED AND TAPED TO ACHIEVE FLUSHED SURFACE W/O STEPPING.
 - UNIT BOUNDING WALLS EXTENT TO UIS OF ROOF.
 - ALL STUD FRAME WALLS TO BE REINFORCED TO BE SUITABLE FOR MOUNTING CABINETRY, BASIN, BENCHES, FIXTURES, FITTINGS AND THE LIKE.
 - CONFIRM GLAZING FRAME WIDTHS AND PACK OUT ANY INTERMEDIARY COLUMNS / SUPPORTS TO ACHIEVE FLUSH FINISH.
 - ALL EXTERNAL LOADBEARING STEEL COLUMNS SHALL BE FIRE PROTECTED.
 - CROSS CHECK WITH INTERIOR DRAWINGS FOR SHOWER WALL HEIGHTS.
 - DIMENSIONS PROVIDED ON WALL TYPE PLANS AND SLAB SETOUT PLANS ARE TO STRUCTURE EXCLUDING FINISHES LAYERS.


- NOTES:
- DIMENSIONS PROVIDED ARE TO STRUCTURE EXCLUDING FINISHES LAYERS.
 - FOR ALL SHOWER LOW WALLS REFER INTERNAL FINISHES DRAWINGS FOR HEIGHTS.

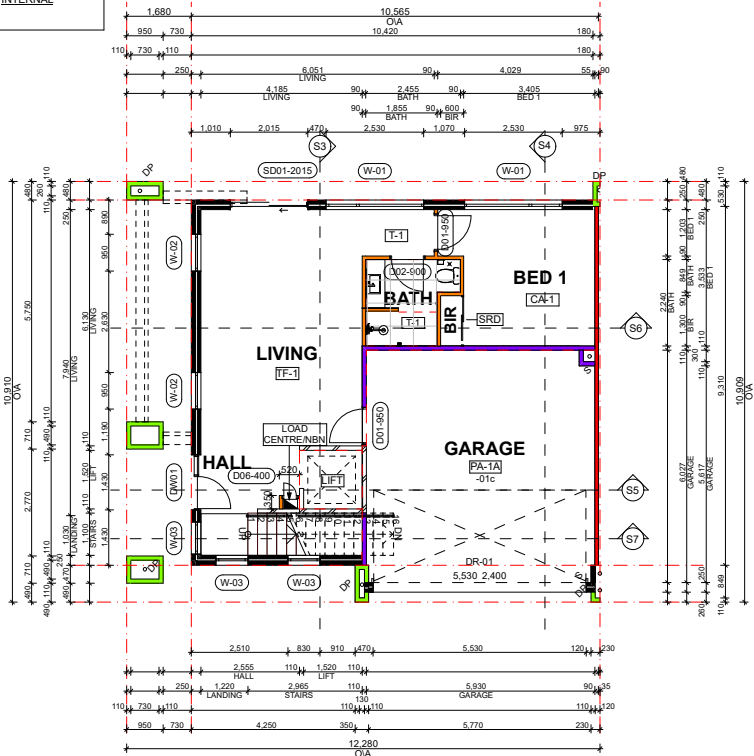

Ground Floor - BP
Scale 1:100

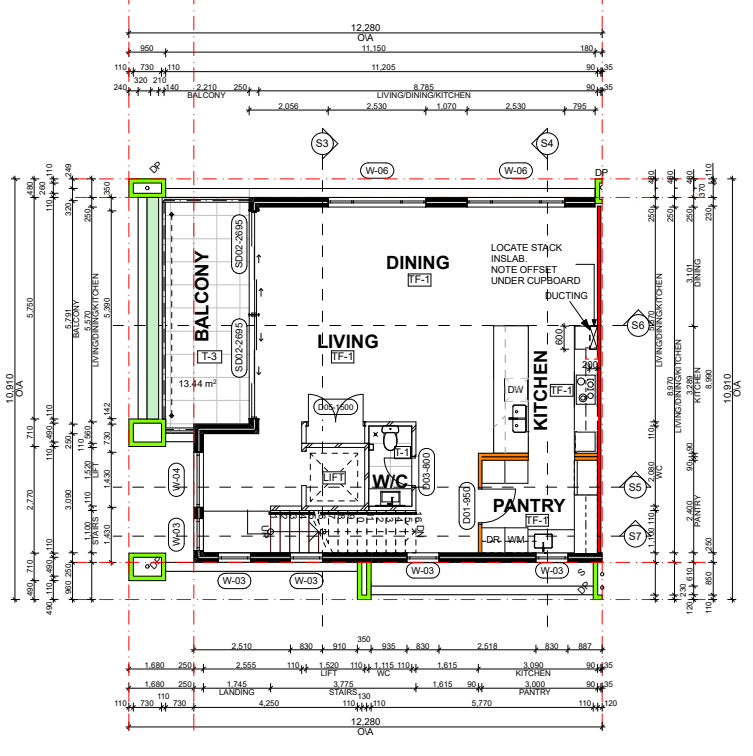

First Floor - Type A
Scale 1:100

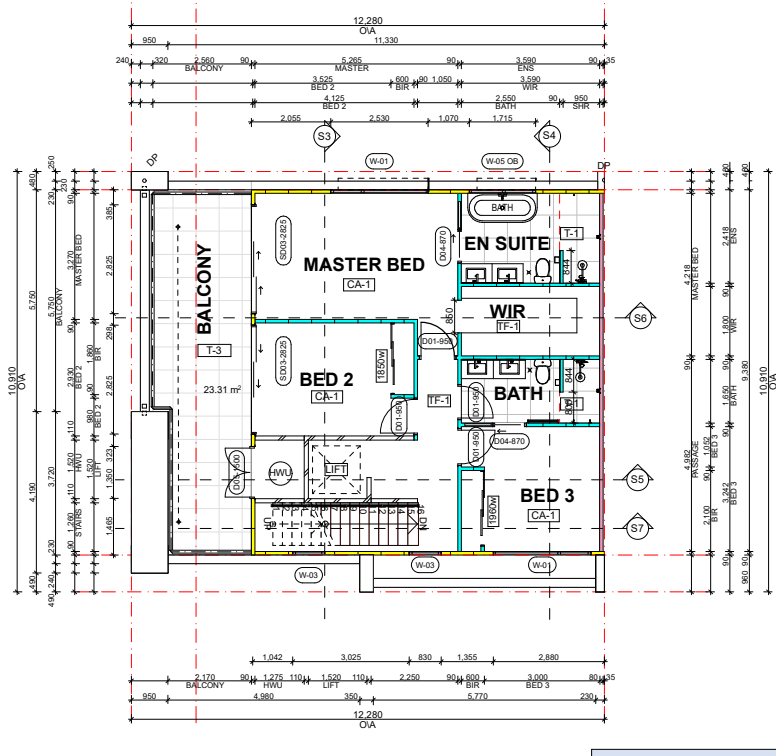

Second Floor - Type A
Scale 1:100

Wall List					
Type Mark	Type Comments	FRL	Rw+Ctr	Insulation	CSR DESIGN GUIDE
WA 011	230mm 90mm CAVITY STEEL PARTITION WALL + 50 ACOUSTICGARD 14kg + 16mm GYROCK FYRECHEK + 10 GYROCKPLUS	90/90/90	≥ 50	75mm Acoustigard	CSR 1355
WA 09	110mm BRICK RENDER + HWP INTERNAL + RENDERED TEXTURE COAT EXTERNAL	90/90/90	≥ 45	-	-
WA 08 (LIFT)	110mm BRICKWORK + HWP INTERNAL	90/90/90	≥ 45	-	-
WA 08	110mm BRICKWORK + HWP INTERNAL	90/90/90	≥ 45	-	-
WA 07	250mm 90mm ACOUSTIC MAXI BRICK + 13mm HWP + 2mm PLASTER SET COAT	90/90/90	≥ 45	-	-
WA 06	90mm STEEL FRAME + 75 ACOUSTICGARD 11kg + 10mm GYROCK PLUS PLASTERBOARD	-/-	≥ 30	75mm Acoustigard	CSR 1008
WA 05	90mm STEEL FRAME + 90mm R2.5 BATTS + HARDIE WEATHER BARRIER + 19mm HARDIE CAVITY BATTENS + 9mm JH EASYLAP. INTERNAL 10mm GYROCK	-/-	-	90mm R2.5 BATTS	JH GUIDELINES
WA 04	110mm FACE PARTITION BRICK WITH RENDERED TEXTURE COAT	90/90/90	≥ 45	-	-
WA 03	110mm MAXI BRICK WITH HWP INSIDE GARAGE	90/90/90	≥ 45	-	-
WA 02	90mm MAXI BRICK WITH HWP BOTH SIDES	90/90/90	≥ 45	-	-
WA 01	250mm 110mm MAXI BRICK + Kingspan AIR-CELL Permavic™ + 13mm HWP	90/90/90	≥ 50	-	-

- WALL NOTES:**
- WET AREAS AND EXTERIOR PLASTERBOARD / FYRECHEK TO BE MOISTURE RESISTANT.
 - PROVIDE DEFLECTION HEAD TO ALL STUD FRAME WALLS.
 - FRL RATINGS ARE TO MEET OR EXCEED BOTH FIRE AND ACOUSTIC REQUIREMENTS, WHICHEVER IS HIGHER.
 - FINISHES TO RETURN INTO OPENING REVEALS U.N.O.
 - INSULATION TO BE READ IN CONJUNCTION WITH ACOUSTIC AND ESC REPORTS.

DATE	REV	REASON FOR ISSUE	BY
31.08.26	B	CDC Issue for Review	
29.07.26	A	Re-Issue for Consultants	
26.06.26	-	Issue for Consultants	

CONTRACTOR TO CHECK ALL DIMENSIONS & LEVELS ON SITE BEFORE COMMENCING ANY WORK OR PREPARING ANY SHOP DRAWINGS. FIGURED DIMENSIONS TAKE PRECEDENCE OVER MEASUREMENTS MANUALLY SCALED OFF DRAWINGS. LARGE SCALE DWGS TAKE PRECEDENCE OVER SMALLER SCALE DWGS.

COMO TOWNHOUSE DEVELOPMENT
124-126 Lockhart St, Como, WA 6152

Sheet Name

Floor Plans

Building Permit


DRAWN	CM	DESIGNED	zz
CHECKED	SM	PRINCIPAL	
DATE	31/08/2026	Principal	
PROJECT No.	630-GRI	DRAWING No.	REV.
Scale as shown - Half Scale @ A3		B1.01	Rev A

URBANIZE


(08) 6243 6405

0438420344


urbanize@urbanize.com.au

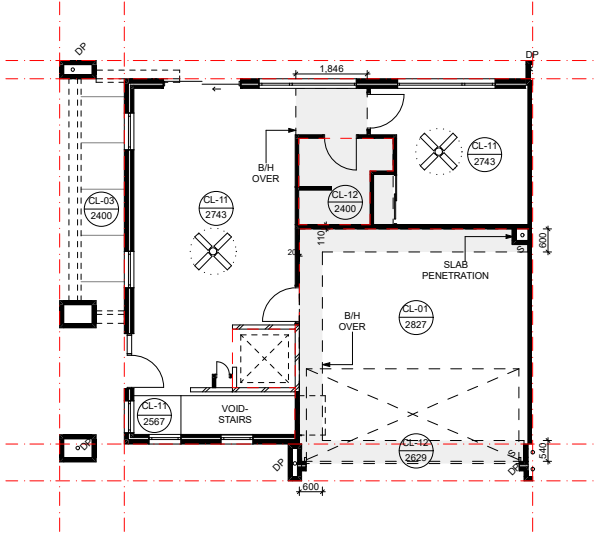

Ground Floor - Ceiling Plan
Scale 1:100

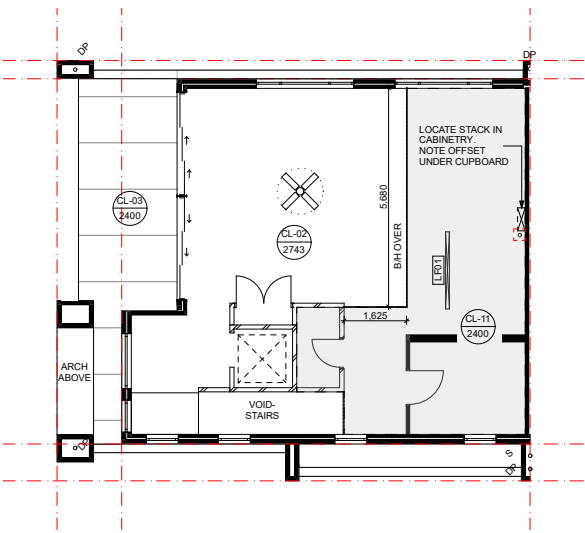

First Floor - Ceiling Plan
Scale 1:100

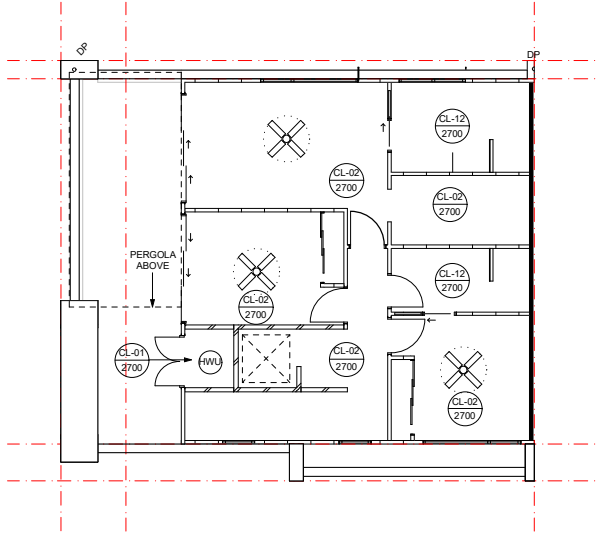

Second Floor - Ceiling Plan
Scale 1:100

- GENERAL NOTES**
1. ALL DIMENSIONS ARE IN MILLIMETRES U.N.O.
 2. WRITTEN DIMENSIONS SHALL TAKE PRECEDENCE OVER SCALED DIMENSIONS.
 3. CONTRACTORS SHALL CARRY OUT WORK IN CONFORMANCE WITH B.C.A./N.C.C. RELEVANT STANDARDS AND THE LOCAL AUTHORITY REQUIREMENTS.
 4. THE MAIN CONTRACTOR IS TO ENSURE THIS DRAWING IS READ IN CONJUNCTION WITH ALL RELEVANT ARCHITECTURAL, STRUCTURAL AND SERVICE CONSULTANT DOCUMENTATION TO ENSURE FULL CO-ORDINATION BETWEEN TRADES PRIOR TO WORK COMMENCEMENT.
 5. LARGE SCALE DRAWINGS SHALL TAKE PRECEDENCE OVER SMALL SCALE DRAWINGS.
 6. SEEK CLARIFICATION FROM SUPERINTENDENT FOR ANY DISCREPANCY.
 7. ALL EXTERNAL FLOOR SURFACES TO FALL AWAY FROM BUILDING.
 8. REFER INTERIOR DOCUMENTATION FOR SETOUTS AND EXACT LOCATION OF CABINETRY, FITTINGS, FIXTURES, PLUMBING, FLOOR WASTES AND TILING.
 9. ALL MATERIALS SHALL BE NEW AND CONFORM TO WHAT IS SHOWN ON THE DRAWINGS AND IN THE SCHEDULES.
 10. THE CONTRACTORS SHALL CHECK AND VERIFY ALL DIMENSIONS ON SITE, PRIOR TO THE COMMENCEMENT OF ANY BUILDING WORK. ALL WINDOW DIMENSIONS ARE NOMINAL AND ARE TO BE MEASURED ON SITE.
 11. THE CONTRACTOR SHALL VISIT THE SITE AND NOTE ALL SITE CONDITION AND ACCESS REQUIREMENTS.
 12. REFER TO WALL TYPES PLANS FOR WALL AND STRUCTURAL COLUMN SETOUTS.
 13. REFER SLAB SETOUT PLANS FOR SLAB SETOUTS.
 14. INSTALL FLASHINGS, EDGE TRIMS AND APPROPRIATE SEALS AS REQUIRED TO ACHIEVE WEATHER TIGHTNESS. FINISH TO BE SAME AS ADJACENT MATERIAL U.N.O.
 15. REFER MASTER MATERIALS SCHEDULE FOR THE FOLLOWING BUILDING TAGS:
 - STRUCTURE SURFACE FINISHES
 - FIXTURES AND FITTINGS
 - FINISHES
 - APPLIANCES
 - TRIMS
 - CEILINGS

Type A		
Floor	Category	Area (m²)
Ground floor	Total	104.22
	Residence	65.42
	Garage	38.8
First floor	Total	105.34
	Residence	91.9
	Balcony	13.44
Second floor	Total	110.02
	Residence	86.71
	Balcony	23.31
Summary	Total Build	319.58
External		
	External paving	35.09
	Landscaping	54.1
	TOTAL	89.19

CEILING LEGEND	
xxx xxx	CEILING MATERIAL TYPE / CORNICE TYPE. REFER ARCH. MATERIALS SCHEDULE FINISHES HEIGHT ABOVE RESPECTIVE INTERNAL STRUCTURAL FLOOR LEVEL
CL-01	CONCRETE SOFFIT FINISH: EXPOSED BARE CONCRETE
CL-02	CONCRETE SOFFIT FINISH: SKIMCOAT FINISH
CL-03	FC SHEETING - NEGATIVE JOINTS FINISH: SKIMCOAT FINISH
CL-11	GENERAL AREAS 10mm PLASTERBOARD FLUSHED AND PAINTED
CL-12	WET AREAS 10mm MR PLASTERBOARD FLUSHED AND PAINTED
CEILING NOTES	
1. NOMINATED CEILING HEIGHTS ARE TAKEN FROM RESPECTIVE FLOOR PLAN SFL.U.N.O.	
2. ALL INTERNAL PLASTERBOARD CEILINGS AND BULKHEADS FLUSHED AND PAINTED, U.N.O. REFER INTERIOR SCHEDULE FOR COLOUR.	
3. ALL EXTERNAL SOFFIT LINING NEGATIVE JOINTS AND PAINTED.U.N.O.	
4. LUMINAIRE SELECTIONS MAY REQUIRE CANISTERS FOR RECESSING INTO CONCRETE SOFFIT BUILDER TO ALLOW.	
5. PLASTERBOARD CEILINGS WITHIN WET AREAS AND EXTERNAL ARE TO BE MOISTURE RESISTANT.	
6. WHERE THERE IS A DROP CEILING TO A HIGH CEILING CORNICE TO THE HIGH CEILING ONLY SQUARE-SET CORNICE FOR DROP CEILING (ie - KITCHENS, ROBES WITH SLIDING DOORS & LAUNDRY CUPBOARDS)	
7. CORNICES TO FULL CEILING PERIMETER INCLUDING WHERE CEILING MEETS BULKHEAD/DROPPED CEILINGS EXCEPTIONS AS BELOW: - WHERE CABINET TOPS FINISH AT CEILING LEVEL STOP CORNICE AT CABINET TOP TRIMS/SCRIBER (DO NOT CONTINUE IN FRONT OF TOP TRIMS) - WHERE THERE IS A BLIND RECESS	
8. REFER TO SERVICE CONSULTANT DRAWINGS FOR FULL EXTENT OF ELECTRICAL AND MECHANICAL SERVICES INCLUDING: - LIGHTING LAYOUT - POWER, DATE AND COMMS - DRY FIRE SERVICE EQUIPMENT - MECHANICAL SERVICES - CEILING ACCESS PANELS FOR SERVICES WITHIN CEILING SPACE - WET AREA EXHAUST	



(08) 6243 6405

0438420344

urbanize@urbanize.com.au

DATE	REV	REASON FOR ISSUE	BY
31.08.26	B	CDC Issue for Review	
29.07.26	A	Re-Issue for Consultants	
26.06.26	-	Issue for Consultants	

CONTRACTOR TO CHECK ALL DIMENSIONS & LEVELS ON SITE BEFORE COMMENCING ANY WORK OR PREPARING ANY SHOP DRAWINGS. FIGURED DIMENSIONS TAKE PRECEDENCE OVER MEASUREMENTS MANUALLY SCALED OFF DRAWINGS. LARGE SCALE DWGS TAKE PRECEDENCE OVER SMALLER SCALE DWGS.

COMO TOWNHOUSE DEVELOPMENT
124-126 Lockhart St, Como, WA 6152

Sheet Name
Floor Plans

Building Permit


DRAWN CM DESIGNED zz

CHECKED SM PRINCIPAL


DATE 31/08/2026 Principal

PROJECT No. 630-GRI DRAWING No. REV.


Scale as shown - Half Scale @ A3  **B1.02** Rev A

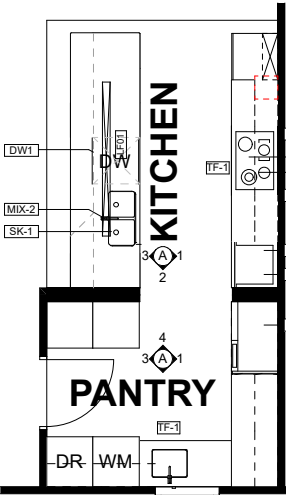


Type A- Kitchen/Pty/Laundry
Scale 1:50

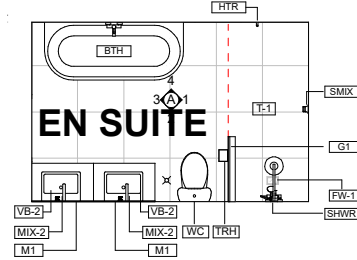

Type A - 2F Ensuite
Scale 1:50

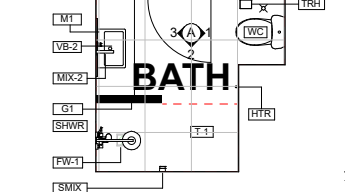


Type A - GF Bath
Scale 1:50

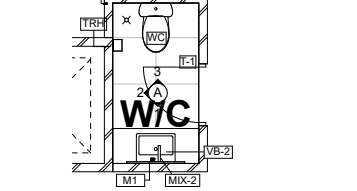


Type A- FF W/C
Scale 1:50

GENERAL NOTES:


- ALL DIMENSIONS ARE IN MILLIMETRES U.N.O.
- IF FIGURED DIMENSIONS OR HEIGHT IS NOT SHOWN, REPORT AND CONFIRM WITH ARCHITECT. ANY DISCREPANCIES WITH DRAWINGS REFER TO ARCHITECT. APPLICABLE AUSTRALIAN STANDARDS
- CONTRACTOR SHALL CARRY OUT WORK IN ACCORDANCE WITH THE SPECIFICATION, THE B.C.A., APPLICABLE AUSTRALIAN STANDARDS, AND LOCAL AUTHORITY REQUIREMENTS. ALLOW FOR TOLERANCES AS INDICATED IN AUSTRALIAN STANDARDS + CODES.
- ALL MATERIALS SHALL BE NEW + CONFIRM TO WHAT IS SHOWN ON THE DRAWINGS AND IN THE SPECIFICATION.
- ARCHITECTURAL DRAWINGS SHALL BE READ IN CONJUNCTION WITH SERVICE CONSULTANT DRAWINGS + SPECIFICATION.

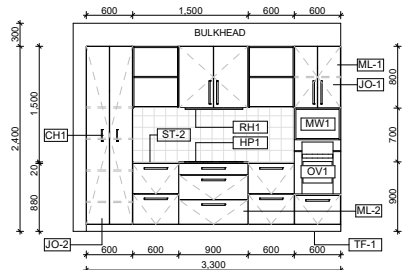


Kitchen 01
Scale 1:50

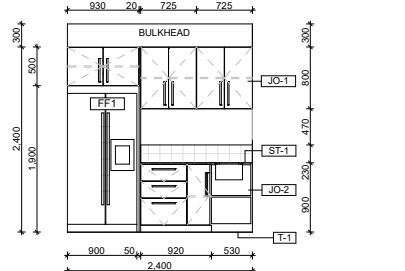


Pty/Laundry 01
Scale 1:50

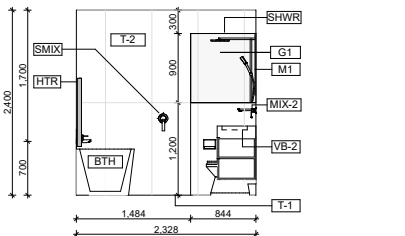


2F Ensuite 1
Scale 1:50

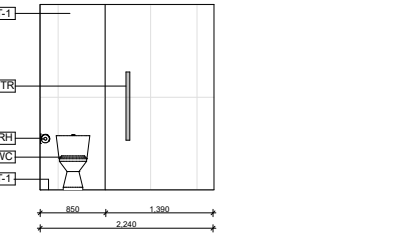


GF Bath 01
Scale 1:50

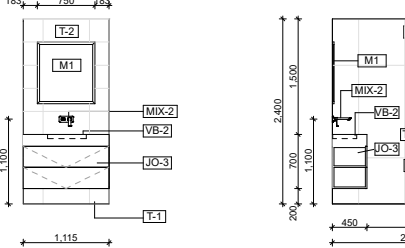


FF WC 01
Scale 1:50

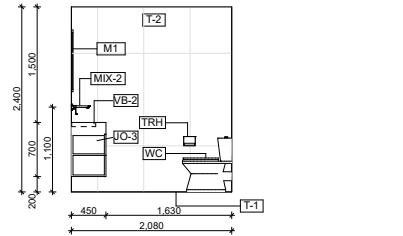


FF WC 02
Scale 1:50

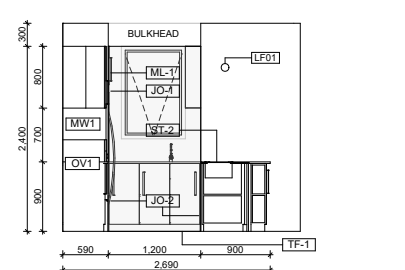


Kitchen 02
Scale 1:50

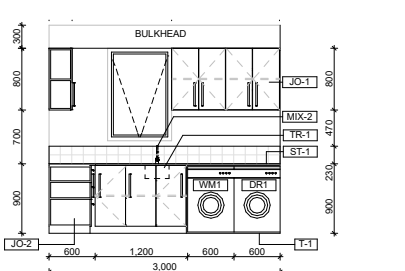


Pty/Laundry 02
Scale 1:50

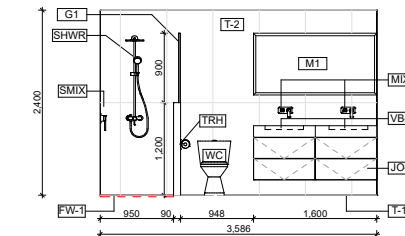


2F Ensuite 2
Scale 1:50

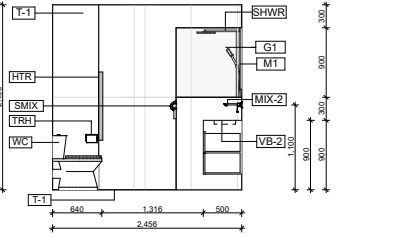


GF Bath 02
Scale 1:50

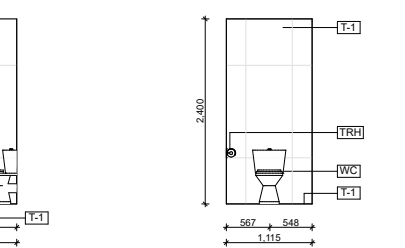

FF WC 03
Scale 1:50

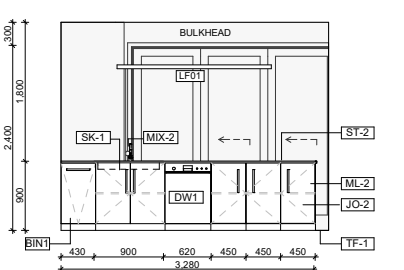


Kitchen 03
Scale 1:50

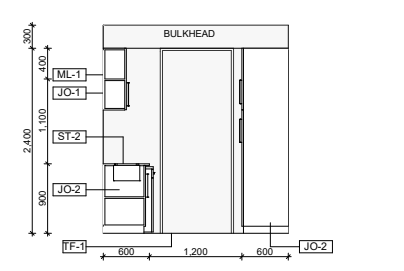


Pty/Laundry 03
Scale 1:50




2F Ensuite 3
Scale 1:50

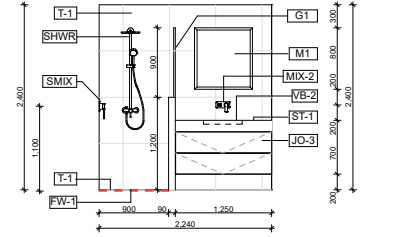

GF Bath 03
Scale 1:50

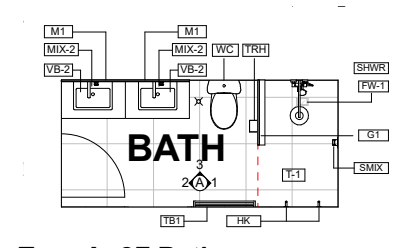


Type A- 2F Bath
Scale 1:50

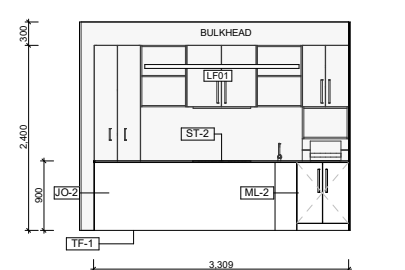

Kitchen 4
Scale 1:50




Pty/Laundry 04
Scale 1:50

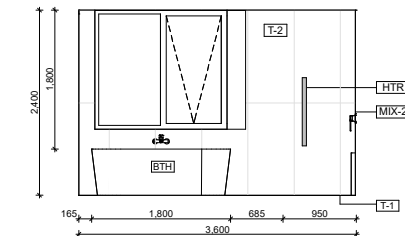


2F Ensuite 4
Scale 1:50



2F Bath 1
Scale 1:50

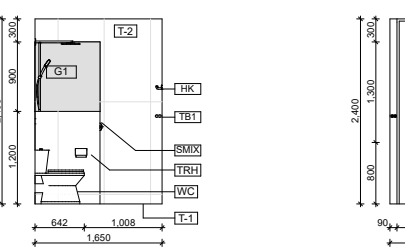

2F Bath 2
Scale 1:50

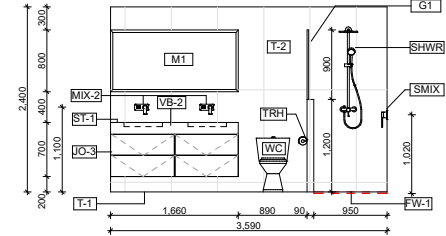

2F Bath 3
Scale 1:50

REFER MASTER MATERIALS SCHEDULE FOR THE FOLLOWING AND MORE:

- STRUCTURE SURFACE FINISHES
- FIXTURES & FITTINGS
- WATERPROOFING SYSTEMS
- FINISHES
- APPLIANCES
- TRIMS

NOTE:

- GLASS SCREEN IS RAISED 10mm ABOVE THE TILING
- WASTE-1 TO ALL BATHROOMS, ENSUITE AND POWDER ROOM
- CISTERN STOP (CS) LOCATION TO BE CONFIRMED
- ALL VANITIES ARE WALL MOUNTED AND WASTE PIPES ARE TO BE RUN IN THE WALLS AND NOT BELOW THE VANITY
- ALL KITCHEN WASTE PIPES TO BE CAST INTO THE SLAB WHERE POSSIBLE

JOINERY NOTE:

- CABINETWORK DETAILS SHOULD BE READ IN CONJUNCTION WITH SPECIFICATIONS, ROOM ELEVATIONS AND FINISHES SCHEDULE.
- ANY CHANGES TO THE SPECIFIED FINISHES OR MATERIALS MUST BE APPROVED BY THE ARCHITECT PRIOR TO PROCEEDING WITH ANY WORKS.
- BENCH TOPS AND CUPBOARD END WHICH ARE EXPOSED AN BUTT UP TO WALLS ARE TO BE SCRIBED TO PROFILE OF WALL AND JUNCTION FILLED WITH APPROVED SEALANT.
- ENSURE STUDWORK WALL HAS ADEQUATE SUPPORT TO HOLD OVERHEAD CABINETS. CO-ORDINATE LOCATION ON-SITE.
- CABINET HINGES AND ANGLES TO BE CO-ORDINATED AND CHECKED ON-SITE.
- ALL SILICON SEAL IN WET AREAS TO BE ANTI-MICROBIAL, ANTI-FUNGICIDAL.
- SOFT CLOSE HINGES AND RUNNERS TO ALL CABINETRY.

DATE	REV	REASON FOR ISSUE	BY
31.08.26	B	CDC Issue for Review	
29.07.26	A	Re-Issue for Consultants	
26.06.26	-	Issue for Consultants	


CONTRACTOR TO CHECK ALL DIMENSIONS & LEVELS ON SITE BEFORE COMMENCING ANY WORK OR PREPARING ANY SHOP DRAWINGS. FIGURED DIMENSIONS TAKE PRECEDENCE OVER MEASUREMENTS MANUALLY SCALED OFF DRAWINGS. LARGE SCALE DWGS TAKE PRECEDENCE OVER SMALLER SCALE DWGS.

COMO TOWNHOUSE DEVELOPMENT
124-126 Lockhart St, Como, WA 6152
Sheet Name
Internal Finishes


DRAWN	CM	DESIGNED	zz
CHECKED	SM	PRINCIPAL	
DATE	31/08/2026	Principal	
PROJECT No.	630-GRI	DRAWING No.	REV.
Scale as shown - Half Scale @ A3		B1.03	Rev A

REFER MASTER MATERIALS SCHEDULE FOR THE FOLLOWING AND MORE:

- STRUCTURE
- SURFACE FINISHES
- FIXTURES & FITTINGS
- WATERPROOFING SYSTEMS
- FINISHES
- APPLIANCES
- TRIMS

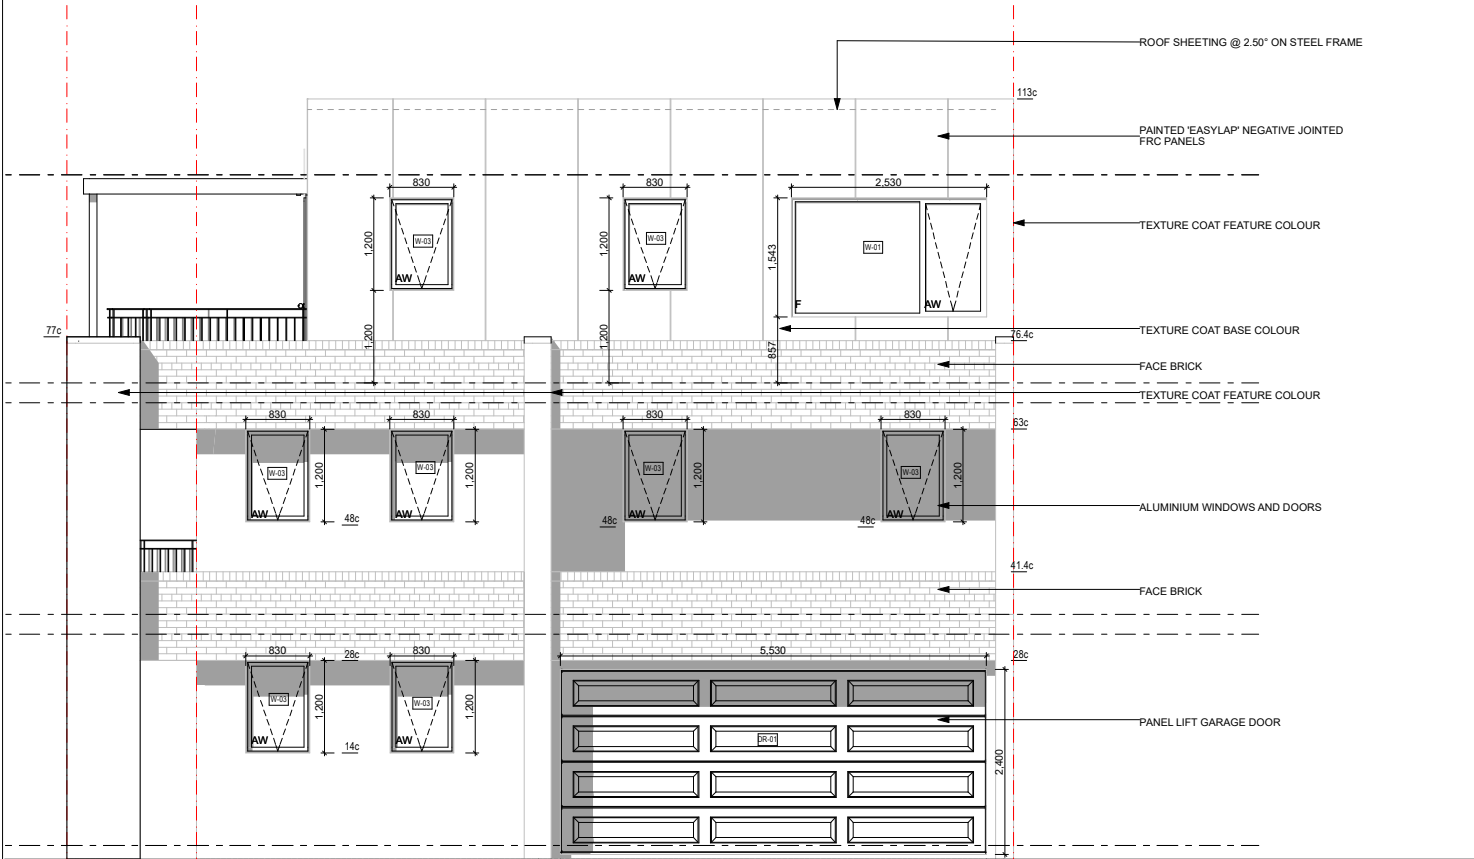

FRONT ELEVATION
Scale 1:50

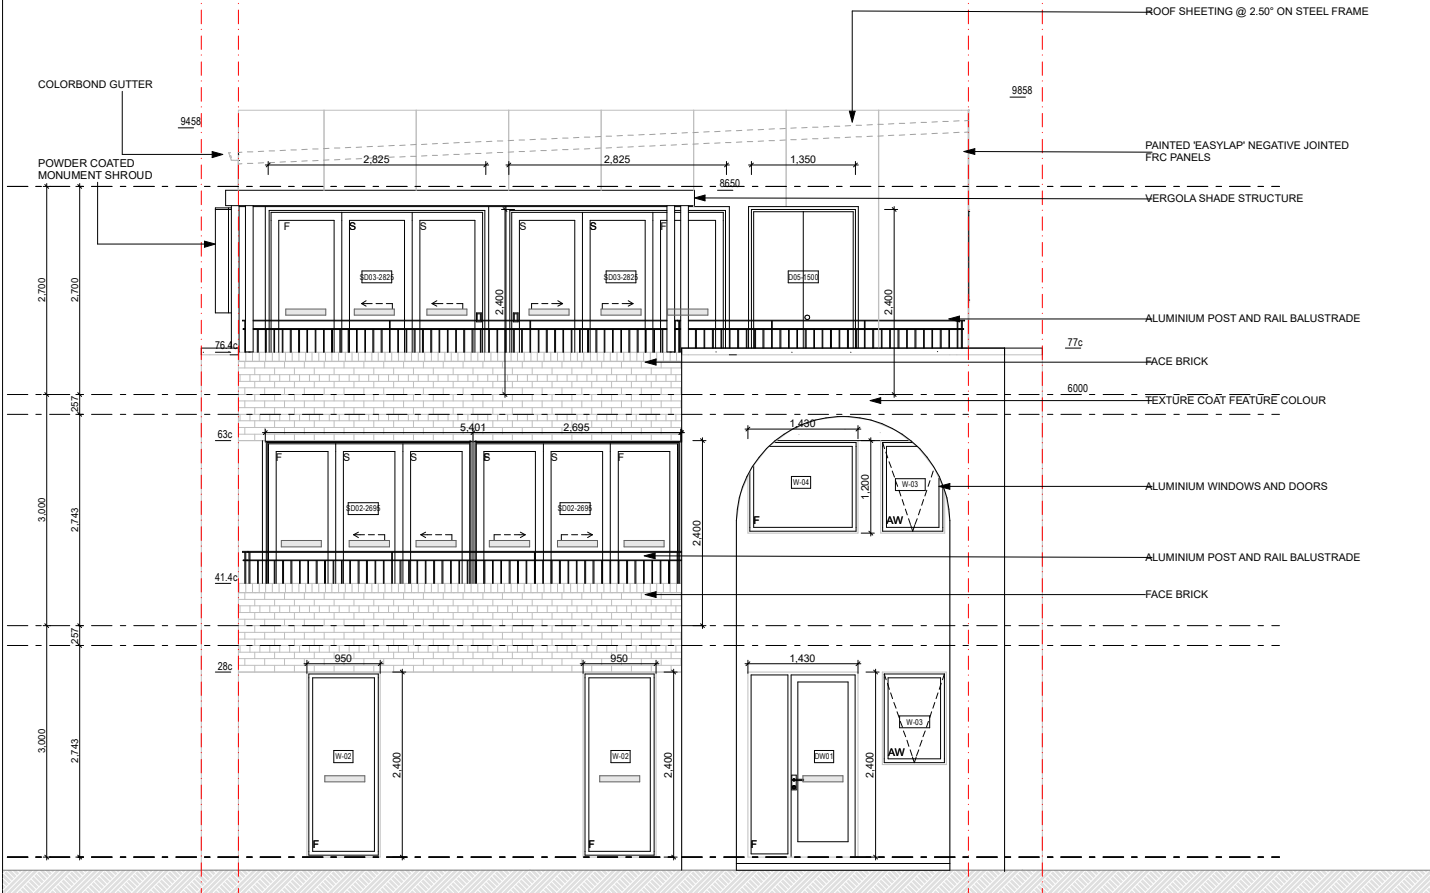

TYPE A SIDE ELEVATION
Scale 1:50

GLAZING AND FRAMING TYPE:
REFER TO ESD & ACOUSTIC REPORT FOR FURTHER INFORMATION

URBANIZE

(08) 6243 6405
0438420344
urbanize@urbanize.com.au

DATE	REV	REASON FOR ISSUE	BY
31.08.26	B	CDC Issue for Review	
29.07.26	A	Re-Issue for Consultants	
26.06.26	-	Issue for Consultants	

CONTRACTOR TO CHECK ALL DIMENSIONS & LEVELS ON SITE BEFORE COMMENCING ANY WORK OR PREPARING ANY SHOP DRAWINGS. FIGURED DIMENSIONS TAKE PRECEDENCE OVER MEASUREMENTS MANUALLY SCALED OFF DRAWINGS. LARGE SCALE DWGS TAKE PRECEDENCE OVER SMALLER SCALE DWGS.


COMO TOWNHOUSE DEVELOPMENT
124-126 Lockhart St, Como, WA 6152

Sheet Name

Elevations and window schedule

Building Permit

DRAWN	CM	DESIGNED	zz
CHECKED	SM	PRINCIPAL	
DATE	31/08/2026	Principal	
PROJECT No.	630-GRI	DRAWING No.	REV.
Scale as shown - Half Scale @ A3		B2.01	Rev A

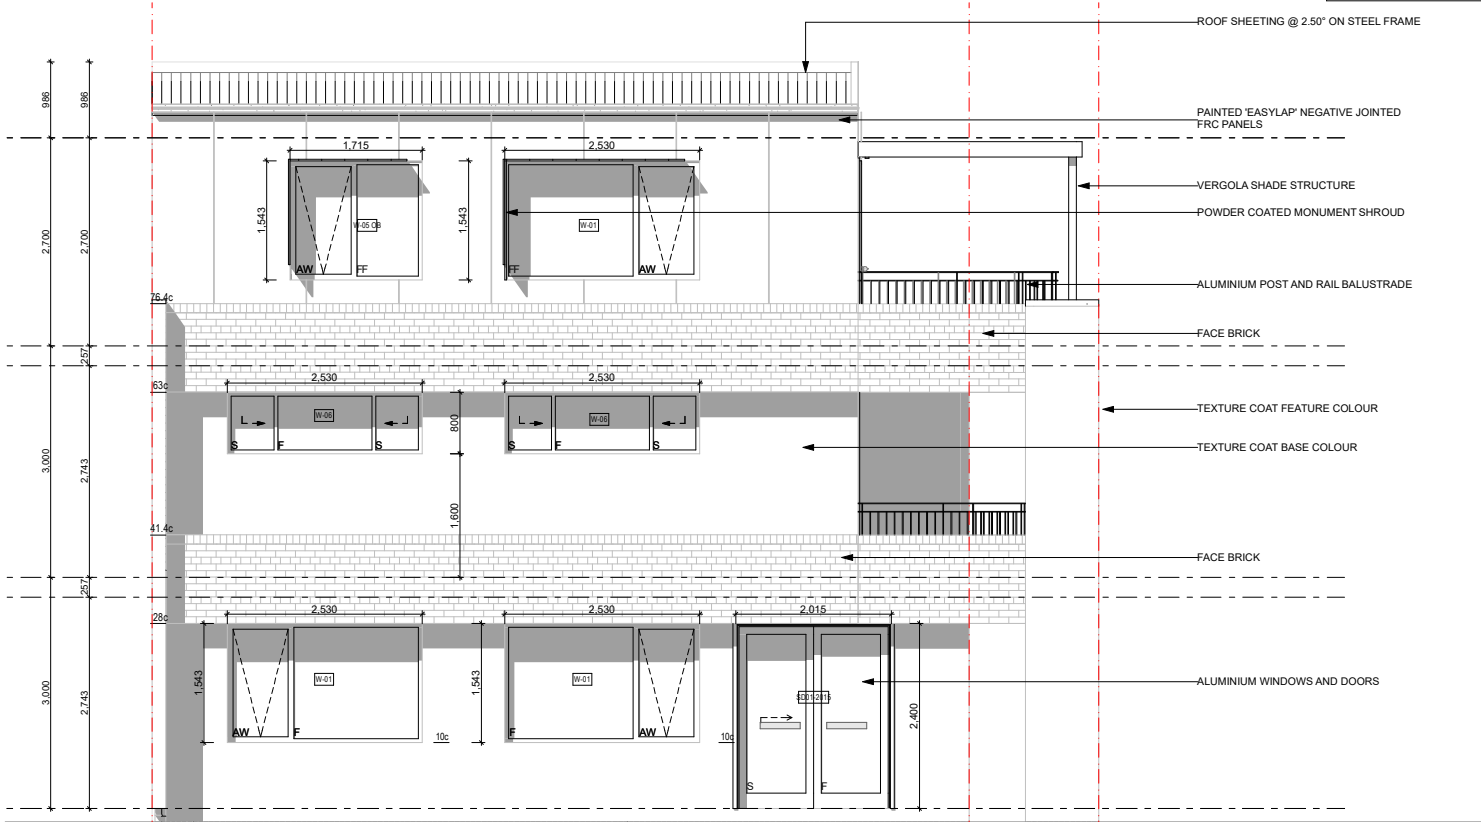

REAR ELEVATION
Scale 1:50


Door & Window Schedule							
Storey	Item	Qty	Type	Frame	Nominal W x H Size	Glazing	Remarks
Ground Floor	D01-950	2	Internal door	Steel	950x2,400	GL-01	
	D02-900	1	Internal door	Steel	900x2,400	GL-01	
	D06-400	1	Internal door	Steel	400x2,100	GL-01	NBN CABINET
	DR-01	1	Garage door	Steel	5,530x2,400	GL-01	
	DW01	1	Entry door	Aluminium	1,430x2,400	GL-01	
	SD01-2015	1	External slider	Aluminium	2,015x2,400	GL-01	
	W-01	2	Fixed window	Aluminium	2,530x1,543	GL-01	
	W-02	2	Fixed window	Aluminium	950x2,400	GL-01	
	W-03	3	Awning window	Aluminium	830x1,200	GL-01	
	W-04	1	Awning window	Aluminium	1,715x1,543	GL-01	
First Floor	D01-950	1	Internal door	Steel	950x2,400	GL-01	
	D03-800	1	Internal door	Steel	800x2,400	GL-01	
	D05-1500	1	Internal door	Steel	1,500x2,100	GL-01	STORAGE
	SD02-2695	2	External slider	Aluminium	2,695x2,400	GL-01	
	W-03	5	Awning window	Aluminium	830x1,200	GL-01	
	W-04	1	Fixed window	Aluminium	1,430x1,200	GL-01	
	W-06	2	Awning window	Aluminium	2,530x800	GL-01	
	W-01	2	Awning window	Aluminium	2,530x1,543	GL-01	
	W-03	2	Awning window	Aluminium	830x1,200	GL-01	
	W-05 OB	1	Awning window	Aluminium	1,715x1,543	GL-01	OBSCURE
Second Floor	D01-950	1	Internal door	Steel	950x2,400	GL-01	
	D01-950	3	Internal door	Steel	950x2,400	GL-01	
	D04-870	2	Internal door	Steel	870x2,400	GL-01	
	D06-1500	1	External door	Steel	1,350x2,400	GL-01	HWU
	SD03-2825	2	External slider	Aluminium	2,825x2,400	GL-01	
	W-01	2	Awning window	Aluminium	2,530x1,543	GL-01	
	W-03	2	Awning window	Aluminium	830x1,200	GL-01	
	W-05 OB	1	Awning window	Aluminium	1,715x1,543	GL-01	OBSCURE
	W-01	2	Awning window	Aluminium	2,530x1,543	GL-01	
	W-03	2	Awning window	Aluminium	830x1,200	GL-01	
	W-05 OB	1	Awning window	Aluminium	1,715x1,543	GL-01	OBSCURE

DOOR AND WINDOW REMARKS

1. PROPRIETARY CAVITY SLIDING DOOR FRAMING SYSTEM COMPLETE WITH INTERNAL FRAME, NOGGINGS, TRACK & WHEEL, HEADER & JAMBS.
2. SOFT-CLOSE TO BOTH LATCH AND CAVITY SIDES
3. DOOR TO CLEAR FFL MAX 10MM
4. PRIVACY LOCK WITH EMERGENCY RELEASE TO ENS, BATH & PDR
5. PRIVACY LOCK WITH EMERGENCY RELEASE TO ENS & BATH & PDR
6. CONTRACTOR TO ADVISE IF ADDITIONAL MULLIONS / TRANSOMS REQUIRED FOR WIND LOAD.
7. ACCESS CONTROL. REFER TO ELECTRIC DOCUMENTATION.
8. DOOR CLOSER TO INTERIOR SIDE.
9. OBSCURED GLAZING
10. KEY LOCKABLE, WEATHER SEAL.
11. KEY LOCKABLE, SMOKE SEAL.
12. KEY LOCKABLE.
13. PROVIDE PACKER ABOVE BETWEEN HEAD AND SOFFIT.
14. ALL SLIDING DOORS ARE TO BE PROVIDED AN OPAQUE BAND TO ABCB HOUSING PROVISIONS 2022 SECTION 8.4.7

GENERAL NOTES (DOORS & WINDOWS):

1. ELEVATIONS SHOWN ARE AS SEEN FROM EXTERNAL OR OUTSIDE OF THE DESIGNATED ROOM U.N.O.
2. REFER FLOOR PLANS FOR DOOR HANDING, TYPE OF WALLS RECEIVING DOOR AND/OR WINDOW FRAMES.
3. REFER ELEVATIONS FOR HANDING AND POSITION OF WINDOWS.
4. REFER DOOR HARDWARE SCHEDULE FOR LOCK AND HARDWARE.
5. REFER FINISHES SCHEDULE FOR COLOURS AND FINISHES.
6. ALUM. AND PVC DOOR/WINDOW SUITES SHALL BE CONCEAL FIXED (I.E. NO VISIBLE POP RIVETS, SCREWS AND THE LIKE).
7. SEEK SUPERINTENDENT'S INSTRUCTION FOR ANY DISCREPANCIES.
8. STEEL AND ALUMINIUM DOOR FRAMES SHALL BE FITTED WITH STIFFENING PLATES OF THE SAME FRAMING MATERIAL TO LOCK, HINGE AND DOOR CLOSER FIXING POINTS.
9. STEEL DOOR FRAMES TO BE PROVIDED WITH CUTOUTS AND BACKPLATES TO SUIT SCHEDULED HINGES. PROVIDE INTEGRATED HINGES OTHERWISE.
10. SUPPLY & INSTALL FLASHING TO ALL EXTERNAL OPENINGS.
11. SUPPLY & INSTALL MATCHING COVER TRIMS, AS REQUIRED.
12. DOOR HANDLES SHALL BE @ 1050 AFFL, U.N.O.
13. FLOOR MOUNTED DOOR STOPS FOR ALL HINGED DOORS.
14. EXTERIOR WINDOWS AND DOOR & WINDOW SUITES SHALL BE INSTALLED WITH SUBSILL AND 70mm HIGH WATER STOP ANGLE ON INTERIOR SIDE OF SILL.
15. ALL EXTERIOR OPERABLE WINDOWS AND SLIDING DOORS TO BE FITTED WITH BLACK ALUMINIUM INSECT MESH WITH MAX 2MM APERTURE, REMOVABLE FOR CLEANING, U.N.O.
16. ALL EXTERIOR OPERABLE WINDOWS, DOORS AND GATES TO BE KEY LOCKABLE, U.N.O.
17. PROPRIETARY FRAME INTEGRATED PERIMETER SEALS FOR EXTERIOR OPERABLE OPENINGS.
18. GLAZING TO COMPLY WITH RELEVANT AUSTRALIAN GLAZING STANDARDS AND CODES.
19. SUBMIT SHOP DRAWINGS TO SUPERINTENDENT FOR APPROVAL PRIOR TO COMMENCING FABRICATION OF DOORS, DOOR WINDOWS, WINDOWS, SKYLIGHTS, GATES, FRIEZE, SCREENS & LOUVRES.
20. ALL OPERABLE WINDOWS TO BE EQUIPPED WITH OPENING RESTRICTORS IN ACCORDANCE WITH CODES AND STANDARDS.
21. DOOR GRILLES - CROSS CHECK WITH MECHANICAL DRAWINGS ON EXTENT.
22. DOOR UNDERCUTS - REFER MECHANICAL DRAWINGS FOR EXTENT.
23. ALL WEATHER STRIPS TO BE SUPPLIED & INSTALLED BY BUILDER.
24. CROSS CHECK WITH ELECTRICAL DRAWINGS FOR RELATED SYSTEMS.

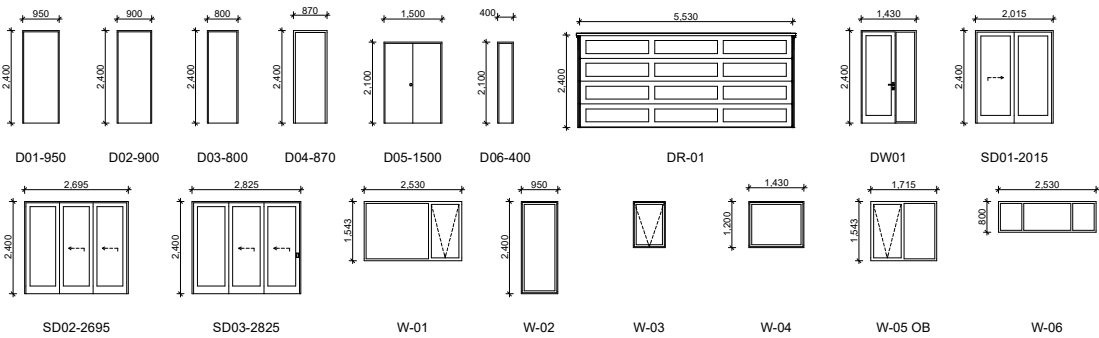

- STRUCTURE SURFACE FINISHES
- FIXTURES & FITTINGS
- WATERPROOFING SYSTEMS
- FINISHES
- APPLIANCES
- TRIMS



CEILING LEGEND	
	CEILING MATERIAL TYPE / CORNICE TYPE. REFER ARCH.
	MATERIALS SCHEDULE
	FINISHES HEIGHT ABOVE RESPECTIVE INTERNAL STRUCTURAL FLOOR LEVEL
CL-01	CONCRETE SOFFIT FINISH: EXPOSED BARE CONCRETE
CL-02	CONCRETE SOFFIT FINISH: SKIMCOAT FINISH
CL-03	FC SHEETING - NEGATIVE JOINTS FINISH: SKIMCOAT FINISH
CL-11	GENERAL AREAS 10mm PLASTERBOARD FLUSHED AND PAINTED
CL-12	WET AREAS 10mm MB PLASTERBOARD FLUSHED AND PAINTED

(08) 6243 6405
0438420344
urbanize@urbanize.com.au


31.08.26	B	CDC Issue for Review	
29.07.26	A	Re-Issue for Consultants	
26.06.26	-	Issue for Consultants	
DATE	REV	REASON FOR ISSUE	BY

CONTRACTOR TO CHECK ALL DIMENSIONS & LEVELS ON SITE BEFORE COMMENCING ANY WORK OR PREPARING ANY SHOP DRAWINGS.
FIGURED DIMENSIONS TAKE PRECEDENCE OVER MEASUREMENTS MANUALLY SCALED OFF DRAWINGS.
LARGE SCALE DWGS TAKE PRECEDENCE OVER SMALLER SCALE DWGS.


Sections

Building Permit

DRAWN		CM	DESIGNED	zz
CHECKED		SM	PRINCIPAL	
DATE		31/08/2026	Principal	
PROJECT No.		630-GRI	DRAWING No.	REV.
Scale as shown - Half Scale @ A3			B3.01	Rev A

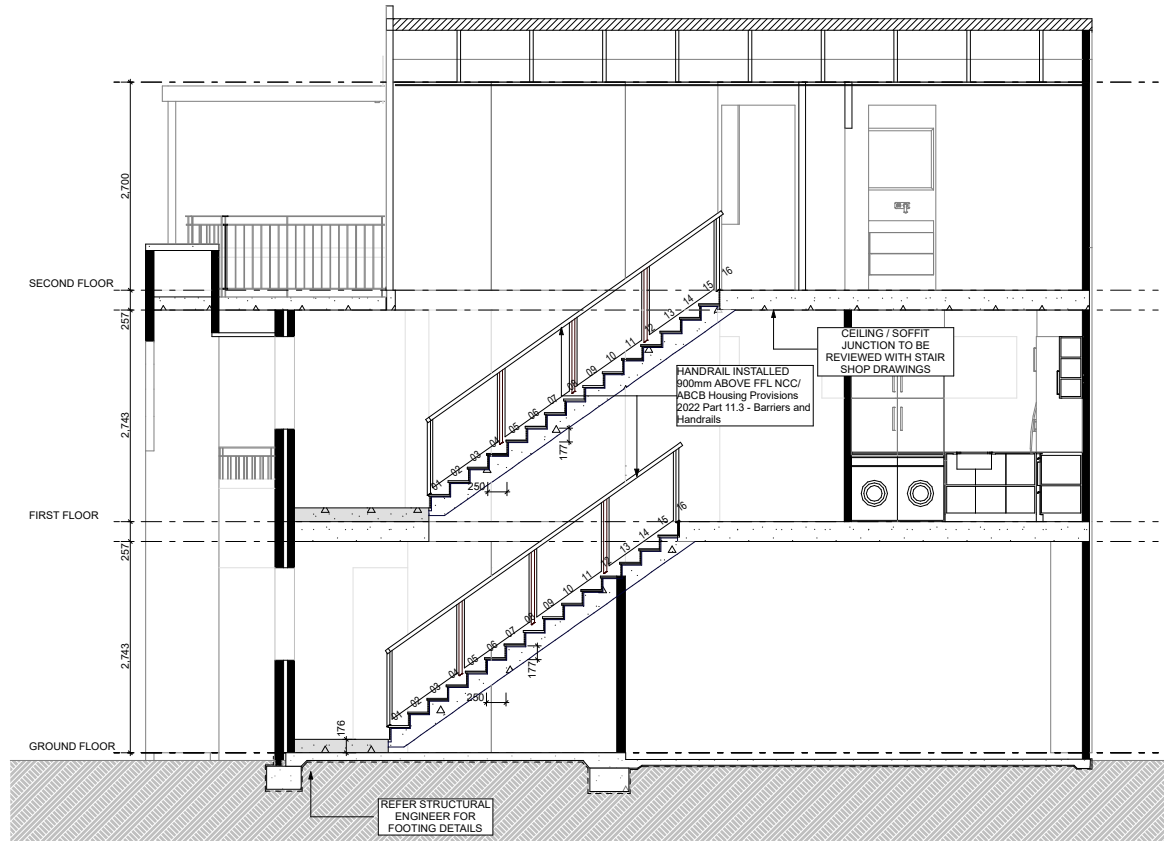

Section 7 - Lift + Stairs
Scale 1:50

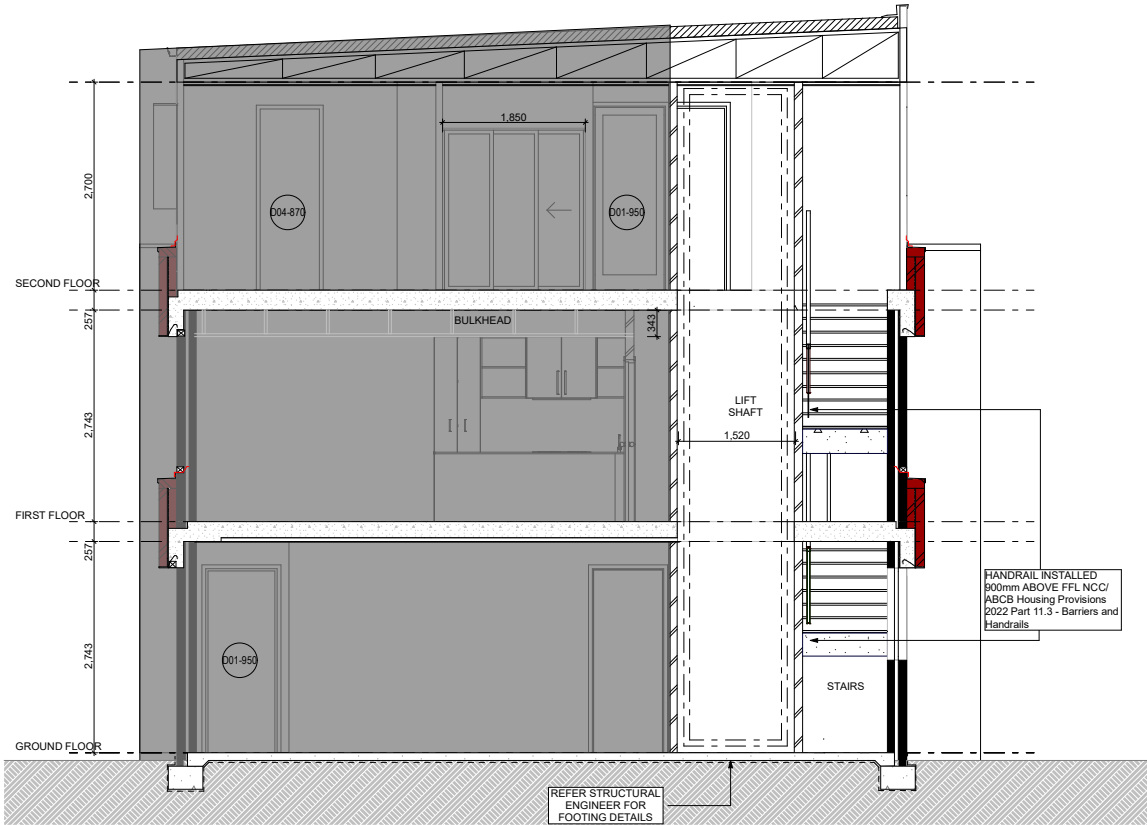


Section 3 - lift + stairs
Scale 1:50

REFER MASTER MATERIALS SCHEDULE FOR THE FOLLOWING AND MORE:

- STRUCTURE SURFACE FINISHES
- FIXTURES & FITTINGS
- WATERPROOFING SYSTEMS
- FINISHES
- APPLIANCES
- TRIMS


NOTES:

- LIFT SHAFT OPENINGS ARE TO BE IN ACCORDANCE WITH LIFT MANUFACTURER'S SHOP DRAWINGS
- STAIR NOSING AS SPECIFIED

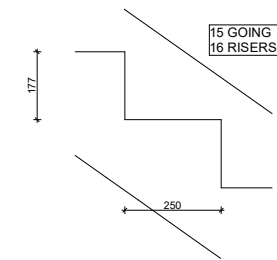


STAIRS DETAIL
Scale 1:10


Stair			
Stair construction is in accordance with NCC/ ABCB Housing Provisions 2022 Part 11.2 - Stairways and Ramp construction			
Riser	Max	Min	Actual
Going	Max	Min	Actual
Slope relationship (2R+G)	Max	Min	Actual
	700mm	550mm	60.4mm

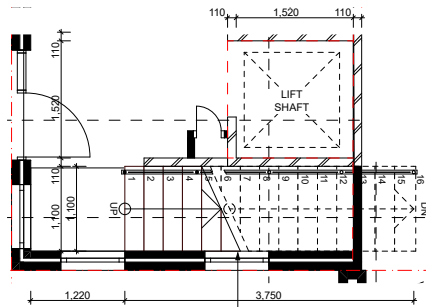


Ground Floor
Scale 1:50

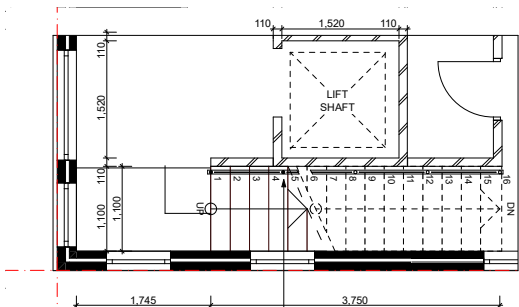

First Floor
Scale 1:50

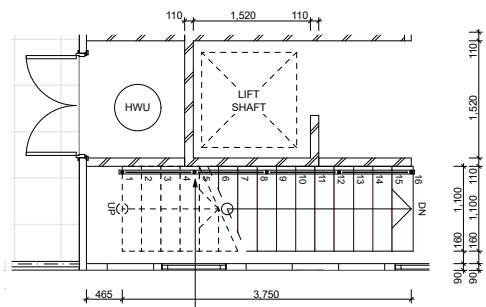

Second Floor
Scale 1:50

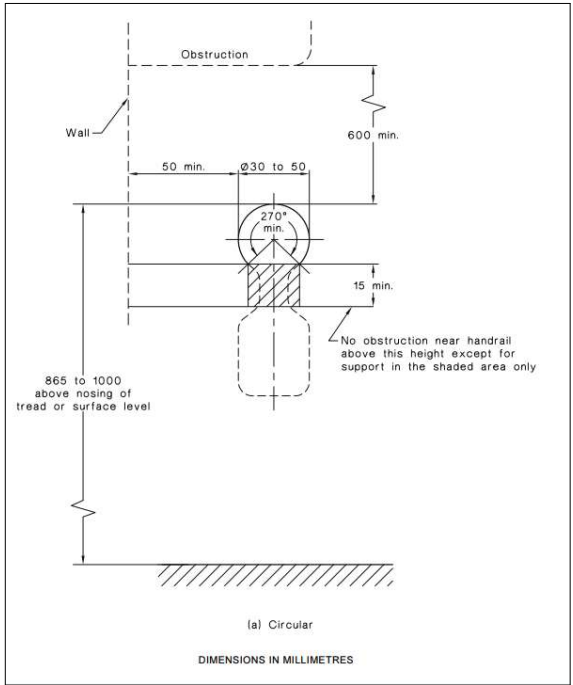

URBANIZE

(08) 6243 6405
0438420344
urbanize@urbanize.com.au

DATE	REV	REASON FOR ISSUE	BY
31.08.26	B	CDC Issue for Review	
29.07.26	A	Re-Issue for Consultants	
26.06.26	-	Issue for Consultants	

CONTRACTOR TO CHECK ALL DIMENSIONS & LEVELS ON SITE BEFORE COMMENCING ANY WORK OR PREPARING ANY SHOP DRAWINGS. FIGURED DIMENSIONS TAKE PRECEDENCE OVER MEASUREMENTS MANUALLY SCALED OFF DRAWINGS. LARGE SCALE DWGS TAKE PRECEDENCE OVER SMALLER SCALE DWGS.

COMO TOWNHOUSE DEVELOPMENT
124-126 Lockhart St, Como, WA 6152
Sheet Name
Stairs + Lift details

Building Permit

DRAWN	CM	DESIGNED	zz
CHECKED	SM	PRINCIPAL	
DATE	31/08/2026	Principal	
PROJECT No.	630-GRI	DRAWING No.	REV.
Scale as shown - Half Scale @ A3		B3.02	Rev A